

ONE AND ONE-HALF INCH = ONE FOOT
 ONE INCH = ONE FOOT
 THREE-QUARTERS INCH = ONE FOOT
 ONE-HALF INCH = ONE FOOT
 ONE-QUARTER INCH = ONE FOOT
 ONE-EIGHTH INCH = ONE FOOT
 ONE-SIXTEENTH INCH = ONE FOOT
 ONE INCH = TWENTY FEET

- SHEET NOTES:**
 THESE SHEET NOTES APPLY TO THIS SHEET ONLY
- FOR ALL MOUNTING HEIGHTS AND CLEARANCES OF ALL ACCESSORIES, SEE SHEET A640.
 - ALL WALL GRID LINES ARE TO CENTER OF WALL FRAMING.
 - ALL DOOR OPENINGS NOT DIMENSIONED SHALL BE SET 4" FROM FACE OF ADJACENT WALL.
 - SEE INTERIOR ELEVATIONS FOR WALL COVERINGS, WAINSCOTTS, ETC. THAT ARE NOT SHOWN HERE.
 - SEE SHEET A811 FOR FINISH INFORMATION NOT SHOWN HERE.
 - PROVIDE ASSISTIVE LISTENING SYSTEM (COMPLYING WITH 11B-219 & 11B-709) IN THE FOLLOWING ROOMS:
 K101 - CLASSROOM
 K102 - CLASSROOM
 K103 - KINDERGARTEN
 K104 - KINDERGARTEN
 K105 - KINDERGARTEN
 K106 - KINDERGARTEN/ECE
 SEE SPECIFICATION SECTION 27 51 26

IDENTIFICATION STAMP
 DIV. OF THE STATE ARCHITECT
 APP: 02-120029 INC.
 REVIEWED FOR
 SS FLS ACS
 DATE: 07/01/2022

DSA APPLICATION NO. 02-120029
 AGENCY APPROVAL

- KEYNOTES:**
 # THESE KEYNOTES APPLY TO THIS SHEET ONLY
- | | |
|-----|---|
| 10 | PLENUM/EQUIPMENT PLATFORM PER MECHANICAL PLAN. |
| 29 | FRAMED TACKBOARD |
| 50 | CONCRETE PAD FOR MECHANICAL EQUIPMENT PER STRUCTURAL PLAN. SLOPE TO DRAIN AWAY FROM STRUCTURE |
| 51 | GROUND-MOUNTED HVAC EQUIPMENT (TYP.). SEE MECHANICAL PLANS. MAINTAIN ALL MANUF. SPEC. CLEARANCES. |
| 57 | ASSISTIVE LISTENING SIGN. SEE DETAIL 7/A640 |
| 104 | WALL-MOUNTED FIRE EXTINGUISHER. MOUNT BOTTOM 4" MIN. A.F.F., 27" MAX. A.F.F. |

EARL LE GETTE ELEMENTARY SCHOOL
 NEW KINDERGARTEN/ECE BUILDING
 4623 KENNETH AVE. FAIR OAKS,
 CA 95628
 SAN JUAN UNIFIED SCHOOL DISTRICT

CONSULTANT
FLINT
 nacht & lewis
 600 Q Street, Suite 100
 Sacramento, CA 95811
 www.nachtlewis.com
 916.329.4000

REGISTERED ARCHITECT
 BRUCE J. MAYFIELD
 No. C-26867
 RENEWAL DATE 10/25
 STATE OF CALIFORNIA


ARCHITECT
 CONSTRUCTION DOCUMENTS

NO.	DESCRIPTION	DATE
1	DSA Plan check	06/28/22

DATE 06/28/2022
 JOB NO. Y2205
 SHEET TITLE

FLOOR PLAN

SHEET NO.
 A111

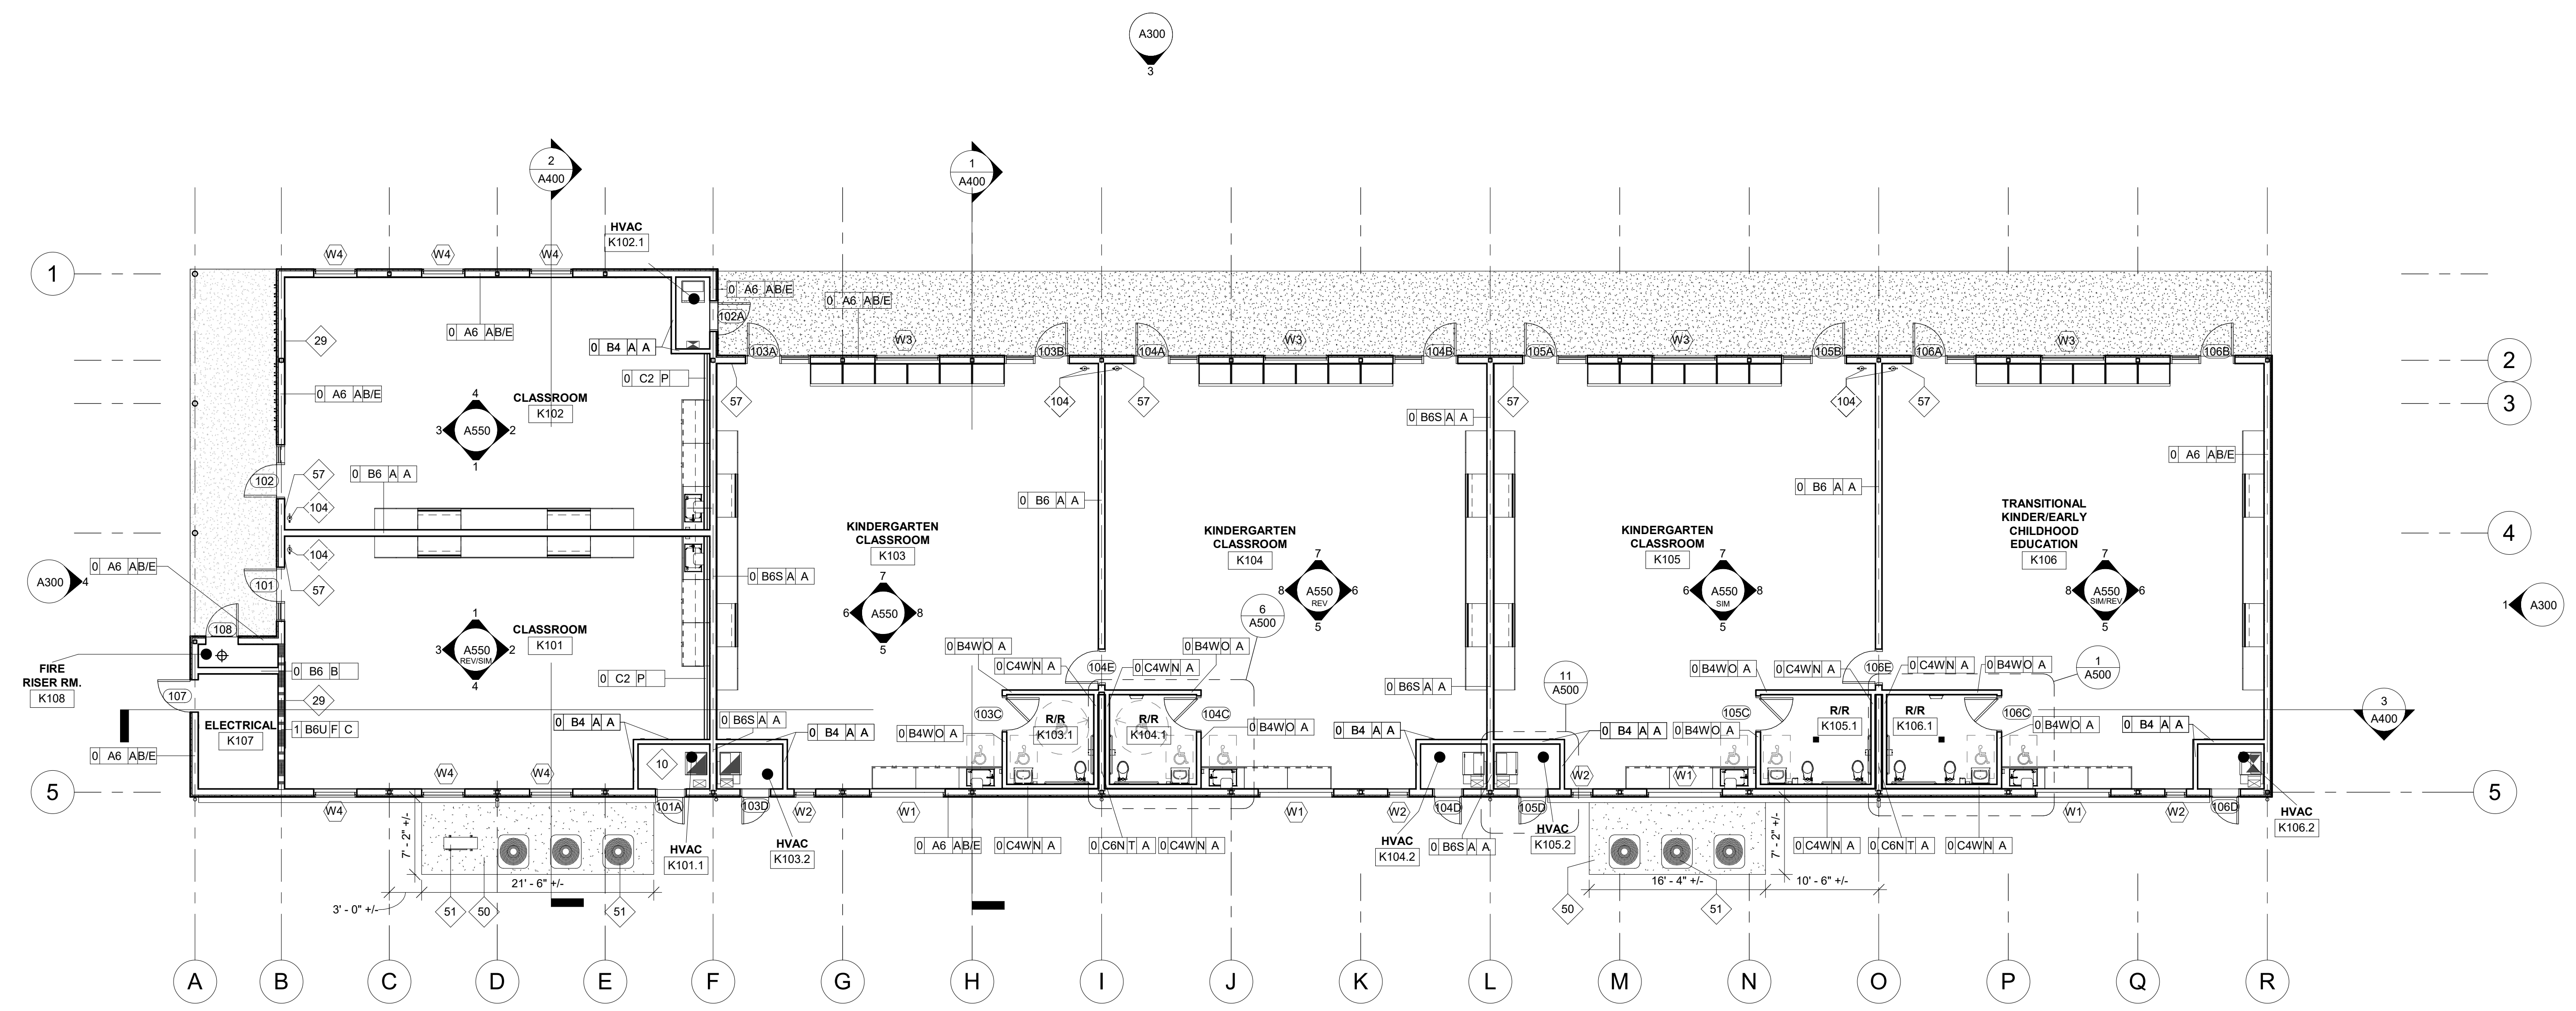

1 FLOOR PLAN
 1/8" = 1'-0"

- LEGEND:**
- 1 HOUR FIRE BARRIER
 - STUD WALL
 - WALL TAG, SEE SHEET A620
 - DOOR TAG, SEE SHEET A710
 - WINDOW TAG, SEE SHEET A710

